

COMPLETE AND ALL DISTURBED AREAS STABILIZED.
CONTRACTOR SHALL REFER TO ARCHITECTURAL PLANS FOR
EXACT LOCATIONS OF ALL DOWNSPOUTS.
DOWNSPOUT PIPES SHALL BE 6" DIAMETER PVC
UNLESS OTHERWISE SPECIFIED.
DOWNSPOUT PIPES SHALL HAVE A MINIMUM OF
12" SLOPE, UNLESS OTHERWISE SPECIFIED.

CONTRACTOR SHALL PROVIDE A FLUSH AND SQUARE CONNECTION OF NEW CONC. WALK TO EXISTING CONC. WALK. INSTALL EXPANSION JOINT AT CONNECTION. PROVIDE SAWCUT OF EXISTING WALK (IF NECESSARY) TO OBTAIN STRAIGHTENED CLEAN JOINT. CONTRACTOR SHALL FIELD VERIFY LOCATION OF EXISTING WALK, AND PROVIDE POSITIVE DRAINAGE AWAY FROM BUILDING & WALKS.


SOUTH PARKING LOT


Chesnut Elementary School

ADA Improvements

10/24/08

SOUTH PARKING LOT

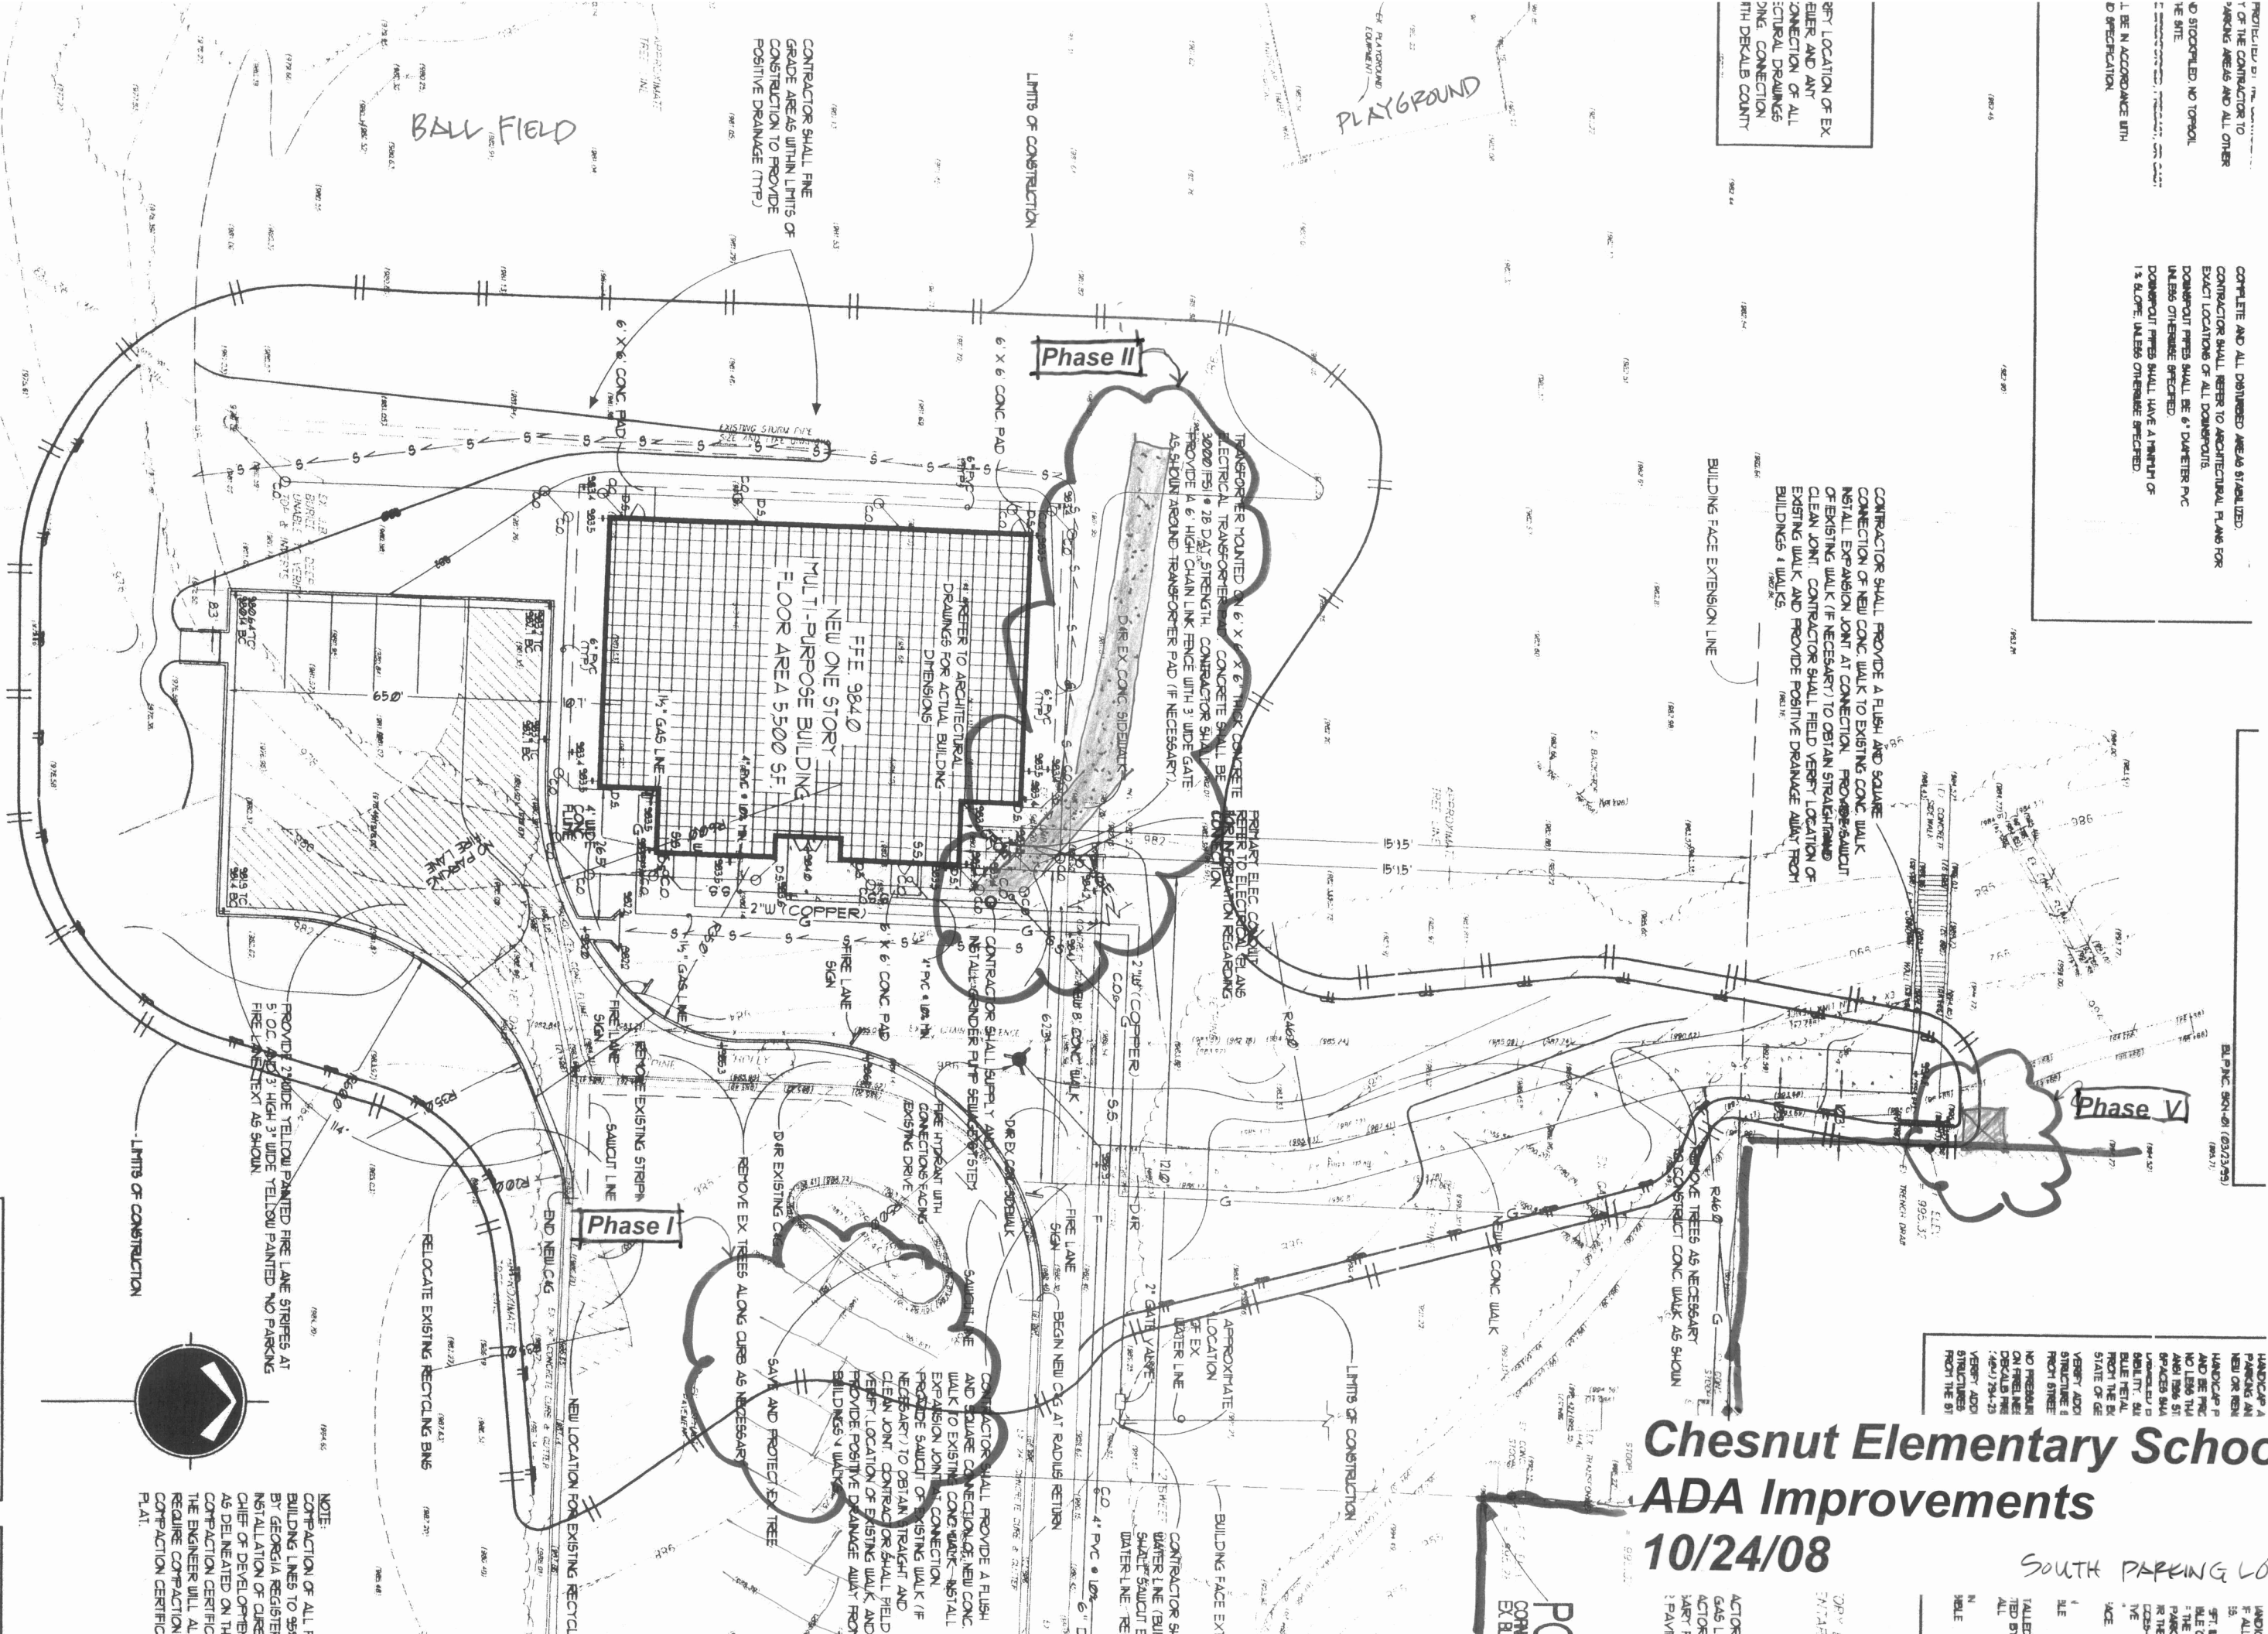

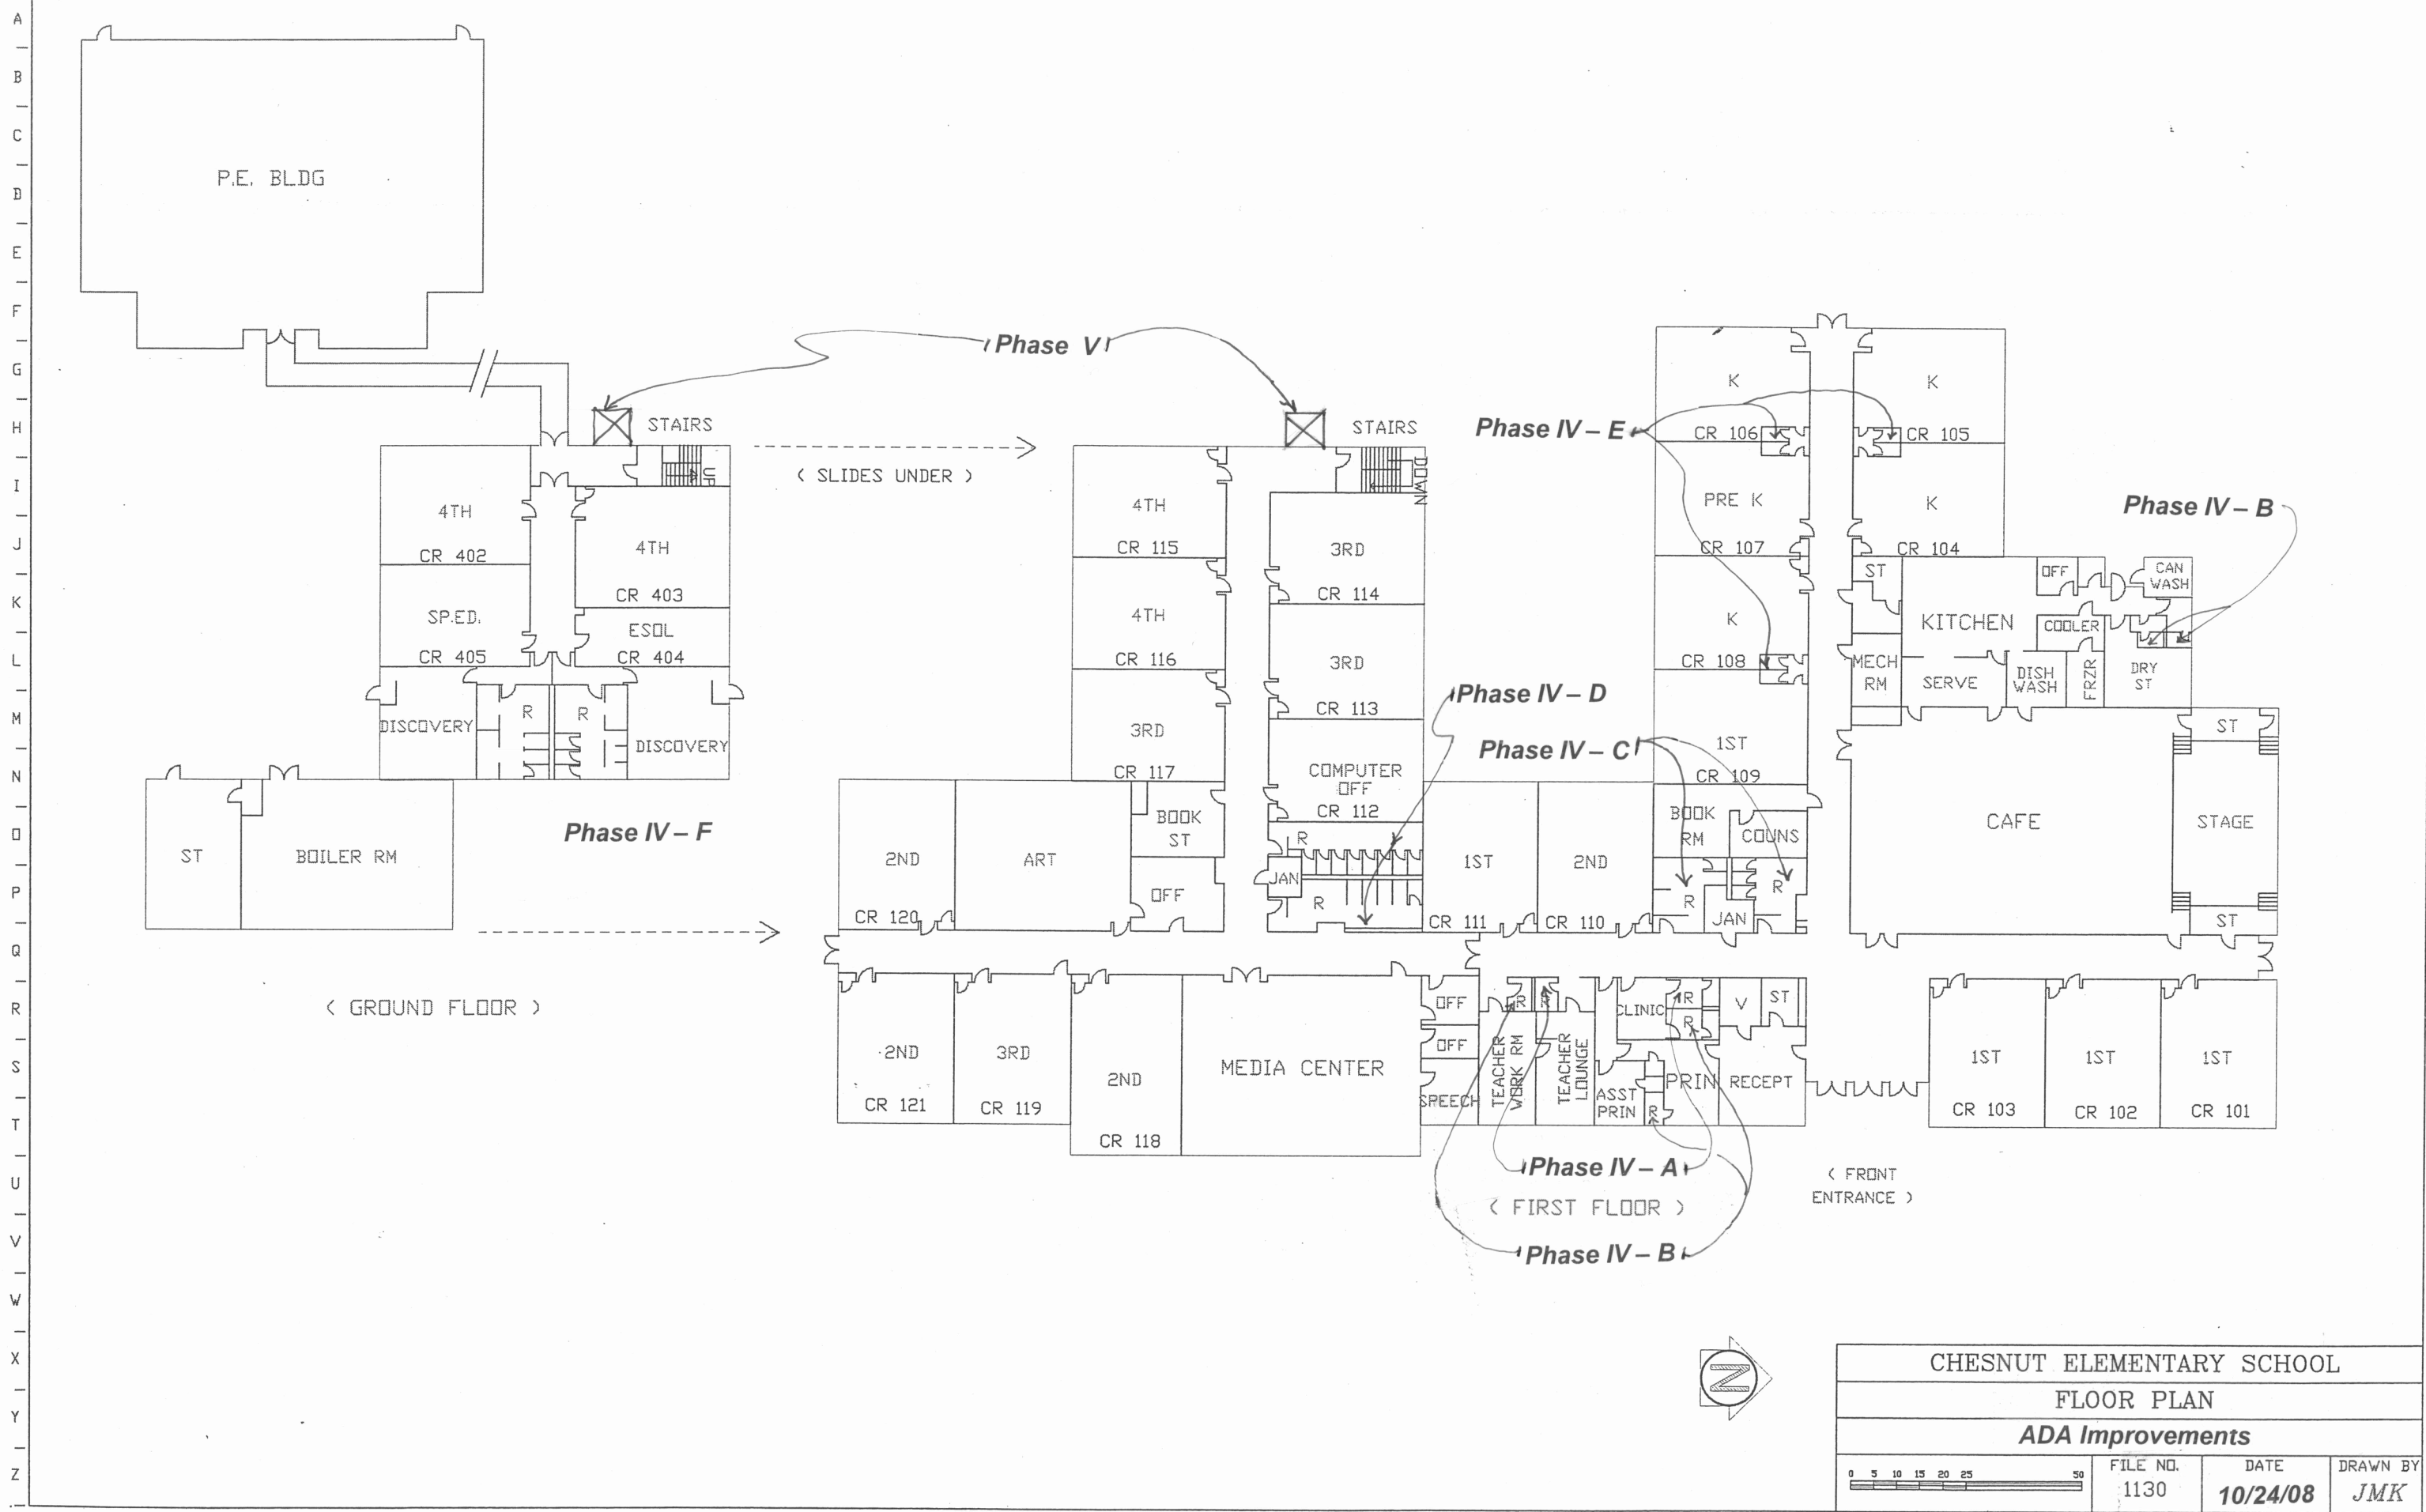

CHESNUT ELEMENTARY SCHOOL			
FLOOR PLAN			
ADA Improvements			
0 5 10 15 20 25 50	FILE NO. 1130	DATE 10/24/08	DRAWN BY JMK